



THIS DRAWING IS THE PROPERTY OF DELAP & WALLER AND MAY ONLY BE USED WITH THEIR WRITTEN APPROVAL.
 DO NOT SCALE FROM THIS DRAWING.
GENERAL NOTES.
 THIS DRAWING IS TO BE READ IN CONJUNCTION WITH ALL OTHER RELEVANT DRAWINGS AND SPECIFICATIONS. ALL DIMENSIONS ARE IN MILLIMETRES UNLESS OTHERWISE STATED.
 THIS DRAWING IS NOT AN INSTALLATION DRAWING. THE CONTRACTOR SHALL BE RESPONSIBLE FOR THE PRODUCTION OF FABRICATION AND INSTALLATION DRAWINGS, SHALL BE FAMILIAR WITH OTHER WORKS PACKAGES WHICH DIRECTLY INTERFERE WITH HIS PACKAGE AND COORDINATE WITH THE FABRICATION AND INSTALLATION DRAWINGS ACCORDINGLY.
 THE CONTRACTOR SHALL BE RESPONSIBLE FOR THE DESIGN, SUPPLY AND INSTALLATION OF SUPPORTS, BRACKETING SYSTEMS, AND SECONDARY STEELWORK SUPPORTS REQUIRED FOR THIS WORKS PACKAGE, UNLESS OTHERWISE STATED.
 SHOULD ANY DISCREPANCIES BE APPARENT IN THIS DRAWING, THE ENGINEER SHALL BE MADE AWARE OF THIS FOR FURTHER ACTION.

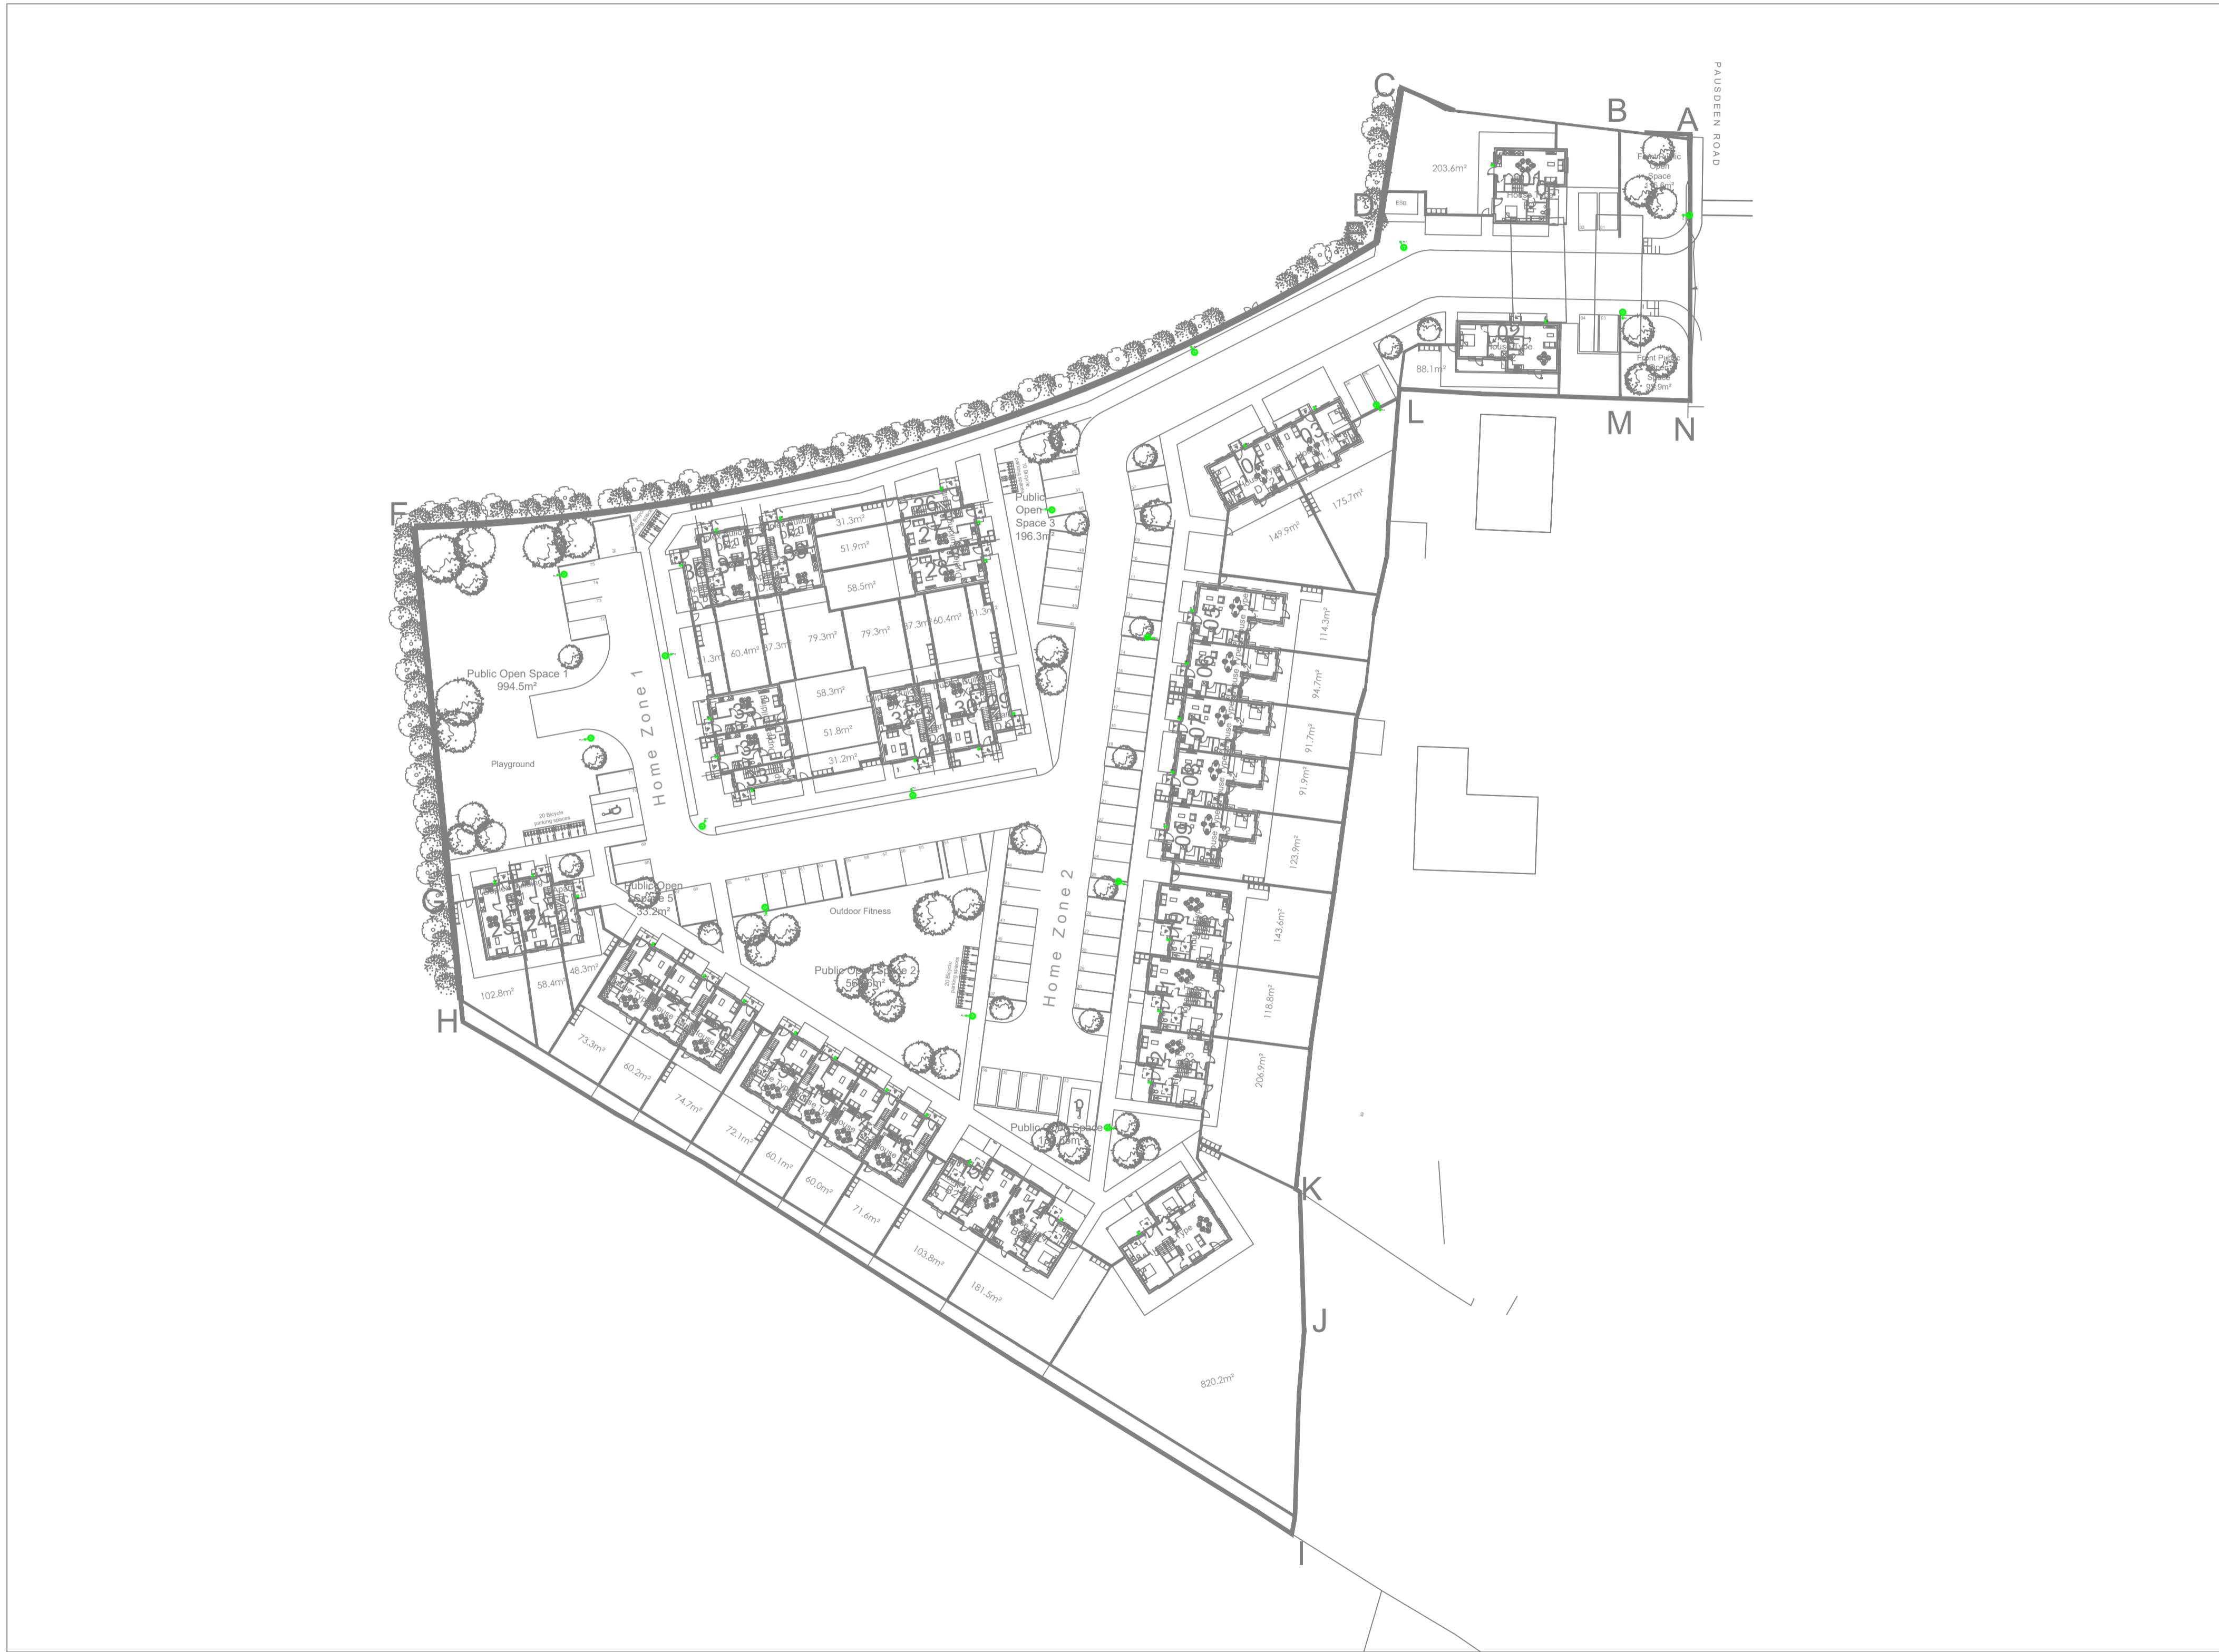

- NOTES**
- CONTRACTOR SHALL ADHERE TO LATEST ILM GENERAL SPECIFICATION FOR PUBLIC LIGHTING DESIGN AND INSTALLATION IN RESIDENTIAL, INDUSTRIAL AND COMMERCIAL DEVELOPMENTS IN THE EU AREA.
 - ALL DETAILS ARE INDICATIVE ONLY AND SUBJECT TO MANUFACTURER'S RECOMMENDATIONS, VENDOR'S CATALOGS, LOCAL AUTHORITY REQUIREMENTS AND PROJECT AND SITE SPECIFIC CONSIDERATIONS.
 - ALL PUBLIC LIGHTING LANTERNS TO BE WIRED IN DUMPS WITH OVERCOURT CABLE.
 - ALL PUBLIC LIGHTING LANTERNS SHALL BE FITTED DIRECTLY ON TOP OF COLUMNS.
 - COLUMNS SHALL BE OF THE TUBULAR STEEL TYPE OR FRAMED DOOR STEEL TO BRIDGE SPACES AT C. MINIMUM THICKNESS OF 3MM. HOT DIP GALVANIZED TO PROTECT.
 - THERE MUST BE AN SEPARATION BETWEEN ESB AND PL MINI PILLARS.
 - JB CABLE CHANNELS REQUIRED TO TERMINATE PL DUCT FROM PL MINI PILLARS TO PL MINI PILLAR DUCTS.
 - READ IN CONJUNCTION WITH LIGHTING REALITY DESIGN REPORT.
- LANTERN TYPE**
- Lantern A - 1x10.0 3xW 4000K ADJUSTABLE STREET LIGHT
 - Lantern B - BEAM ADJUSTABLE 10x T8 LED WALL LIGHT

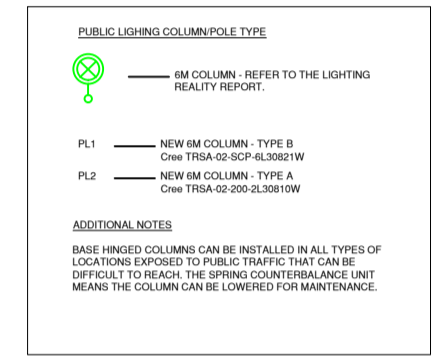

P	21.01.22	PRELIMINARY ISSUE	ADB	PB
Revision	Date	Details	Drn	Chkd

DELAP & WALLER
 +353 1 535 5900
 dublin@delapandwaller.com
 www.delapandwaller.com

Antrim Dublin London

ARCHITECT

PROJECT
**ARDCLOUGH ROAD
 CELBRIDGE
 Co. KILDARE**

TITLE
STREET LIGHTING LAYOUT

DESIGNED PB	DATE OCT 2021	FLOOR
DRAWN GM	SCALE 1:500@A1	

DRG No. 21042-E-604	DRG REV. P
-------------------------------	----------------------

DRG STATUS
PRELIMINARY